

RESOLUTION NO. 3673

**A RESOLUTION OF THE CITY COUNCIL OF THE CITY OF SOLEDAD
ACCEPTING IMPROVEMENTS ASSOCIATED WITH THE FRONT STREET
REVITALIZATION PROJECT FROM GRANITE ROCK PAVEX, CONSTRUCTION
DIVISION**

WHEREAS, on January 7, 2004, the City Council awarded a contract for the Front Street Revitalization Project to Granite Rock Pavex, Construction Division, Inc., in the amount of \$3,024,068 00; and

WHEREAS, the contract included the construction of streetscape, storm drain, sewer main, water main, streetlights, a Park & Ride lot and diagonal parking between the Streets of Benito and East on Front Street; and

WHEREAS, the original contract with Granite Rock Pavex, Construction Division for construction services was \$3,024,068 00 and the final contract amount, with approved contract change orders, was \$3,024,406 97, which was \$338.97 greater than the amount awarded, and

WHEREAS, City Engineer Mark Thomas & Co has reported to the City that the improvements have been completed in accordance with the approved improvement plans and City of Soledad Standards and Specifications, and

WHEREAS, the Public Works Director recommends that the City accept the Project as complete, thereby authorizing the issuance of the formal notice of completion and release of Project bonding.

NOW THEREFORE, BE IT HEREBY RESOLVED by the City Council of the City of Soledad that the City does hereby accept improvements associated with the Front Street Revitalization Project From Granite Rock Pavex, Construction Division, all as listed in Exhibit "A", attached hereto and by this reference incorporated herein.

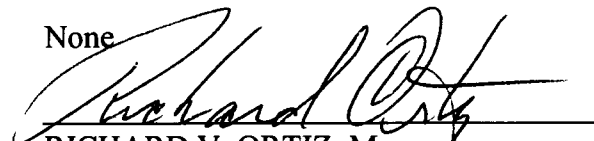
PASSED AND ADOPTED by the City Council of the City of Soledad at a regular meeting duly held on the 21st day of September 2005, by the following vote:

AYES, and in favor thereof, Councilmembers. Christopher Bourke, Stefanie De La Rosa, Patricia Stephens, Mayor Pro Tem Juan Saavedra, Mayor Richard Ortiz

NOES, Councilmembers. None

ABSTAIN, Councilmembers. None

ABSENT, Councilmembers. None

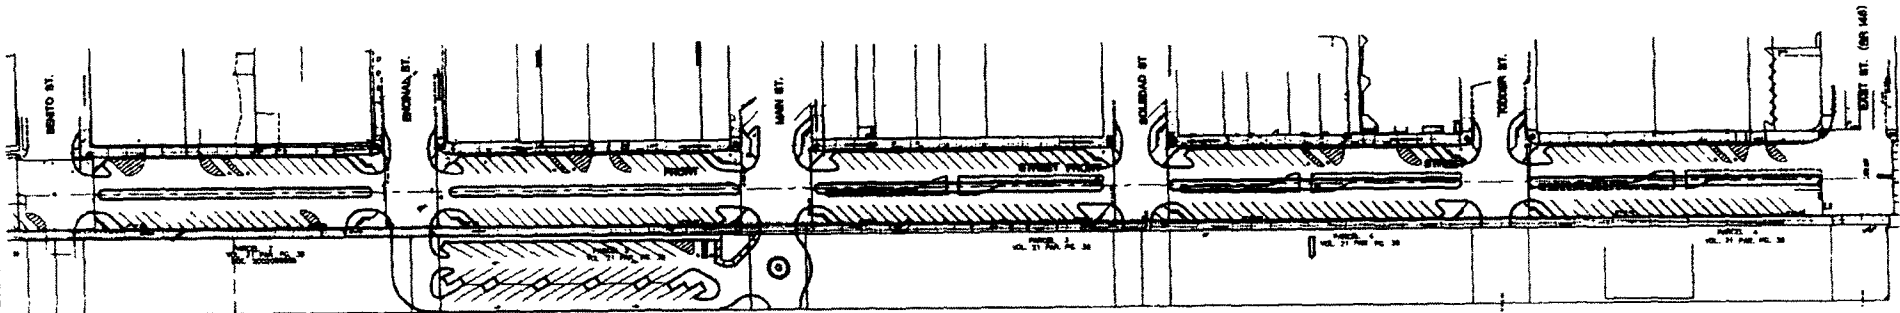
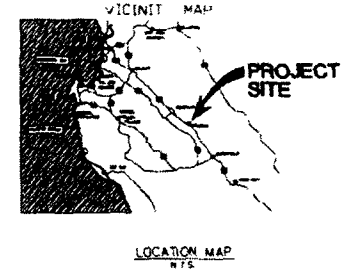

RICHARD V. ORTIZ, Mayor

ATTEST


NOELIA F. CHAPA, City Clerk

CITY OF SOLEDAD 2003 FRONT STREET REVITALIZATION BENITO STREET TO EAST STREET

PROJECT NO. 2002-05
CITY OF SOLEDAD, COUNTY OF MONTEREY
STATE OF CALIFORNIA



SHEET INDEX

SHEET NO.	DESCRIPTION
C1	COVER SHEET
CD1-CD2	DEMOLITION PLANS
CS1-CSS	SURFACE IMPROVEMENT PLANS INCLUDING PLAN/PROFILES
CU1-CU5	UNDERGROUND IMPROVEMENT PLANS
CD61-CD63	DETAILS & NOTES
CD61-CD63	UTILITY BOX REPLACEMENT LOCATION & BOX SCHEDULE
CS51-CSS2	SIGNING & STRIPING PLANS
CXC	CROSS SECTIONS
E1.0	ELECTRICAL SYMBOLS, ABBREVIATIONS & DETAIL
E2.0-E2.1	ELECTRICAL SITE PLAN
E3.0	ELECTRICAL DETAILS
L11-L1.7	LANDSCAPE LAYOUT AND FINISH PLAN
L21-L2.7	IRRIGATION PLAN
L31-L3.7	PLANTING PLAN



MARK THOMAS & COMPANY, INC.
Professional Engineering, Surveying and Planning Services
210 CAPITOL STREET, SUITE #2, SALINAS, CALIFORNIA 93901
TEL: (831) 754-4412 FAX: (831) 754-4413

DESIGNED BY: WAG
DRAWN BY: Hector G.
CHECKED BY: WAG
DATE: 10/27/03

APPROVED _____ DATE _____

DATE	REVISION	BY

SCALE: HORIZONTAL 1"=60'
JOB# E1-2002-102
APPROVED: _____
DATE: _____ R.E. NO. 42180 EXP. 3/31/04

COVER SHEET
2003 FRONT STREET
REVITALIZATION PROJECT

