

RESOLUTION NO. 3674

**A RESOLUTION OF THE CITY COUNCIL OF THE CITY OF SOLEDAD
ACCEPTING CONCRETE ASSOCIATED WITH THE FRONT STREET
REVITALIZATION PROJECT FROM B-4 CONCRETE**

WHEREAS, on August 16, 2004, the City Council authorized the execution of a new contract with B-4 Concrete for concrete work associated with the Front Street Revitalization Project for \$151,069 07, and

WHEREAS, the contract included the construction of a portion of the decorative concrete sidewalk construction work between the streets of Benito and East on Front Street; and

WHEREAS, the original contract amount with B-4 Concrete was \$151,069 07 and the final contract amount with approved contract change orders was \$159,124 04, \$8,054 97 greater than the amount awarded, and

WHEREAS, Mark Thomas & Co has reported to the City that the improvements have been completed in accordance with the approved improvement plans and City of Soledad Standards and Specifications, and

WHEREAS, the Public Works Director recommends that the City accept the Project as complete, thereby authorizing the issuance of the formal notice of completion and retention of 10% to cover withholdings.

NOW THEREFORE, BE IT HEREBY RESOLVED by the City Council of the City of Soledad, that the City does hereby accept concrete improvements associated with the Front Street Revitalization Project From B-4 Concrete, all as listed in Exhibit "A", attached hereto and by this reference incorporated herein.

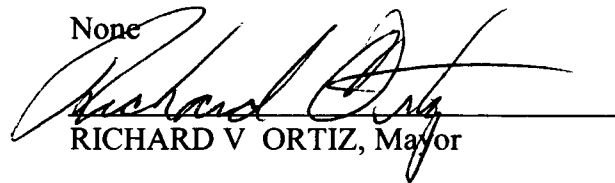
PASSED AND ADOPTED by the City Council of the City of Soledad at a regular meeting duly held on the 21st day of September 2005, by the following vote:

AYES, and in favor thereof, Councilmembers. Christopher Bourke, Stefanie De La Rosa, Patricia Stephens, Mayor Pro Tem Juan Saavedra, Mayor Richard Ortiz

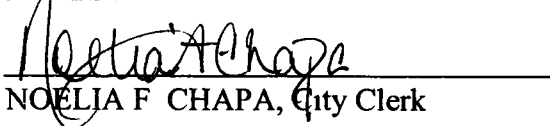
NOES, Councilmembers None

ABSTAIN, Councilmembers. None

ABSENT, Councilmembers. None

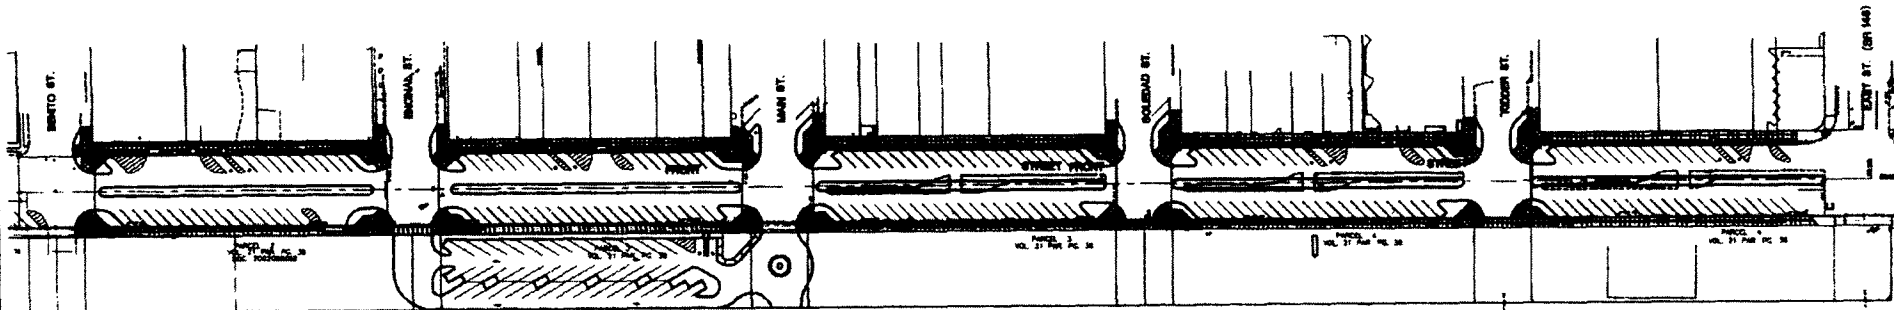
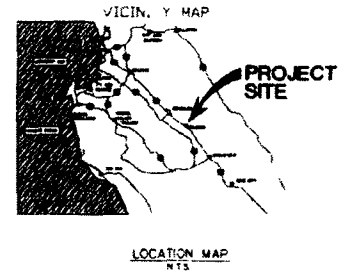

RICHARD V. ORTIZ, Mayor

ATTEST

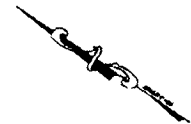

NOELIA F. CHAPA, City Clerk

CITY OF SOLEDAD 2003 FRONT STREET REVITALIZATION BENITO STREET TO EAST STREET

PROJECT NO. 2002-05
CITY OF SOLEDAD, COUNTY OF MONTEREY
STATE OF CALIFORNIA



PROJECT MAP
SCALE: 1" = 60'



SHEET INDEX

SHEET NO.	DESCRIPTION
CS	COVER SHEET
CS1-CDS	DEMOLITION PLANS
CS1-CSS	SURFACE IMPROVEMENT PLANS INCLUDING PLAN/PROFILES
CS1-CUS	UNDERGROUND IMPROVEMENT PLANS
CS1-CDS	DETAILS & NOTES
CS1-CDS	UTILITY BOX REPLACEMENT LOCATION & BOX SCHEDULE
CS1-CSS2	SIGNING & STRIPING PLANS
CSC 1	CROSS SECTIONS
F10	ELECTRICAL SYMBOLS, ABBREVIATIONS & DETAIL
E2.0-E2.1	ELECTRICAL SITE PLAN
E3.0	ELECTRICAL DETAILS
L1.1-L1.7	LANDSCAPE LAYOUT AND FINISH PLAN
L2.1-L2.7	IRRIGATION PLAN
L3.1-L3.7	PLANTING PLAN



MARK THOMAS & COMPANY, INC.
Providing Engineering, Surveying, and Planning Services
210 CENTER STREET SUITE #12 SALINAS, CALIFORNIA 93901
TEL: (831) 754-6612 FAX: (831) 754-6613

DESIGNED BY: **WAG**
DRAWN BY: **Hector C**
CHECKED BY: **WAG**
DATE: **10/27/03**

APPROVED _____ DATE _____

DATE	REVISION

SCALE: HORIZONTAL 1"=50'
JOB # **02-2002-100**
APPROVED: _____
DATE: _____ R.E. NO. 42160 EXP 3/31/04

COVER SHEET
2003 FRONT STREET
REVITALIZATION PROJECT



SOLEDAD CALIFORNIA